

RIM RAIL TO ACT AS STRUCTURAL HEADER FOR ALL OPENINGS

- DRAWING LIST:
1. FLOOR PLAN
 2. EXTERIOR ELEVATIONS
 3. FOUNDATION
 4. ELECTRICAL LAYOUT
 5. HEAT LAYOUT
 6. CROSS SECTION
 7. PLUMBING SCHEMATIC

- CODE REQUIREMENTS:
- 2012 ONTARIO BUILDING CODE
 - 2021 ONTARIO ELECTRICAL SAFETY CODE
 - CAN/CSA A277
- INSULATION REQUIREMENTS: AS PER ENERGY EFFICIENCY FORM

- CLIMATIC DATA
- DESIGN DATA: ESPANOLA, ON
 - GROUND SNOW LOAD: 2.3 kPa
 - RAIN LOAD: 0.4 kPa
 - DESIGN ROOF SNOW LOAD: 1.7 kPa
 - 1/50 WIND: 0.42 kPa
 - DEGREE DAYS: 4920

Rev.	Description


MAPLE LEAF HOMES, INC.
 FREDERICTON, NB
 CANADA

Drawing Title:
**NORTH SHORE QUALITY HOMES
 BUTTERFLY MODEL**

ORDER # 47667 MASSEY, ON

Date:	APRIL 5/23
Scale:	3/16" = 1'-0"
Dim. by:	AW
Chk'd by:	CE
Drawing No.	NSCH0923
Sheet No.	1

- NOTE:
1. ROOF TRUSSES TO BE SEALED BY ONTARIO ENGINEER
 2. ALL GUARDS, STAIRS, AND DECKS INSTALLED ON-SITE TO BE IN CONFORMANCE WITH THE 2012 ONTARIO BUILDING CODE TO BE CONSTRUCTED ON-SITE BY OTHERS, NOT INCLUDED IN THIS DRAWING PACKAGE.
 3. ALL LUMBER TO BE SPF #1/2.
 4. ALL WORK, INCLUDING WOOD CONNECTIONS TO BE COMPLETED IN ACCORDANCE WITH PART 9 OF THE 2012 ONTARIO BUILDING CODE.
 5. SINGLE JACK STUD TO SUPPORT UNITS UNLESS OTHERWISE NOTED.
 6. ATTIC AND CRAWL SPACE ACCESS TO BE PROVIDED IN CONFORMANCE WITH 2012 ONTARIO BUILDING CODE WHERE APPLICABLE.
 7. 9.29.2.1. WATERPROOF WALL FINISH REQUIRED TO A HEIGHT NOT LESS THAN:
 - 1.8M ABOVE THE FLOOR IN SHOWER STALLS
 - 1.2M ABOVE THE RIM OF BATHTUBS EQUIPPED WITH SHOWER
 - 400MM ABOVE THE RIM OF BATHTUBS WITHOUT SHOWER

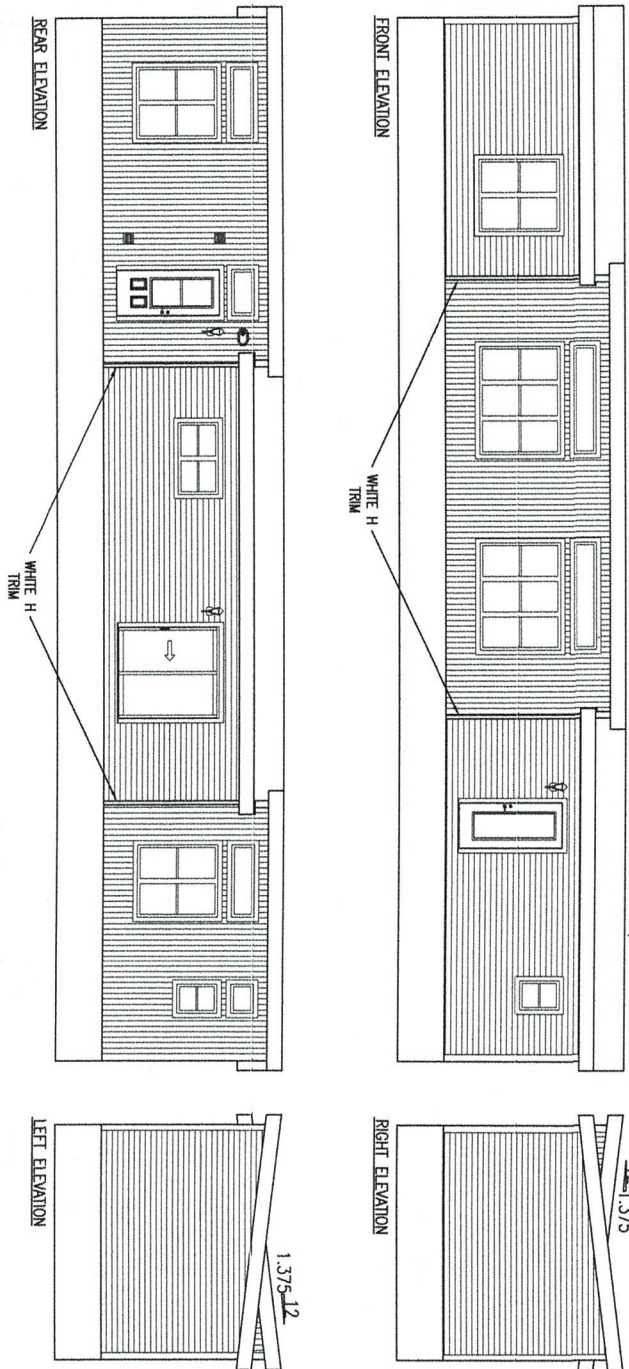

CODE REQUIREMENTS
 - 2012 ONTARIO BUILDING CODE
 - 2021 ONTARIO ELECTRICAL SAFETY CODE
 - CAN/CSA A277
 - INSULATION REQUIREMENTS: AS PER ENERGY EFFICIENCY FORM

CLIMATIC DATA
 - DESIGN DATA: ESPANOULA, ON
 - GROUND SNOW LOAD: 2.3 kPa
 - RAIN LOAD: 0.4 kPa
 - DESIGN ROOF SNOW LOAD: 1.7 kPa
 - 1/50 WIND: 0.42 kPa
 - DEGREE DAYS: 4920

Rev.	Description

MAPLE LEAF HOMES, INC.
 FREDERICTON, NB
 CANADA

Drawing Title:
**NORTH SHORE QUALITY HOMES
 BUTTERFLY MODEL**
 ORDER # 47667 MASSEY, ON

Date:	APRIL 5/23	Sheet No. 2
Scale:	1/8" = 1'-0"	
Drn. by:	AW	
CHK'd by:	CE	
Drawing No.	NSQH0923	